

Elevation A 1 Car - Sheet List	
Sheet Number	Sheet Name
ElevA-1Car-Pg1	Front & Rear Elevations
ElevA-1Car-Pg2	Side Elevations
ElevA-1Car-Pg3	1st Floor Plan
ElevA-1Car-Pg4	2nd Floor Plan
ElevA-1Car-Pg5	Roof Plan
ElevA-1Car-Pg6	Electrical & Flooring Plan
Pg7	Interior Elevations
Pg8	Slab Penetrations




1 Front Elevation - Elev A - 1 Car Garage
1/8" = 1'-0"



2 Rear Elevation - Elev A - 1 Car Garage
1/8" = 1'-0"

Area Schedule (Elev A 1Car)	
Name	Area
Heated	
1st Floor	708 SF
2nd Floor	1002 SF
	1710 SF
Unheated	
Front Porch	48 SF
Garage	234 SF
	282 SF
Under Roof	1992 SF

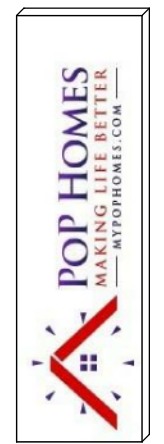

CONTRACTOR AND BUILDER SHALL REVIEW ENTIRE PLAN TO VERIFY CONFORMANCE WITH ALL CURRENT APPLICABLE CODES IN EFFECT AT TIME OF CONSTRUCTION. BY USING THESE DRAWINGS FOR CONSTRUCTION IT IS UNDERSTOOD THAT CONFORMANCE WITH ALL APPLICABLE CODES IS THE RESPONSIBILITY OF THE BUILDER AND CONTRACTOR.

1710 LH - Elevation A 1Car

Front & Rear Elevations

Lot #:

Job #:

Address:

Community:

Last Revision Date:

11-18-21

Sheet #:


ElevA-1Car-Pg1



CONTRACTOR AND BUILDER SHALL REVIEW ENTIRE PLAN TO VERIFY CONFORMANCE WITH ALL CURRENT APPLICABLE CODES IN EFFECT AT TIME OF CONSTRUCTION. BY USING THESE DRAWINGS FOR CONSTRUCTION IT IS UNDERSTOOD THAT CONFORMANCE WITH ALL APPLICABLE CODES IS THE RESPONSIBILITY OF THE BUILDER AND CONTRACTOR.



① Left Elevation - Elev A - 1 Car Garage
1/8" = 1'-0"

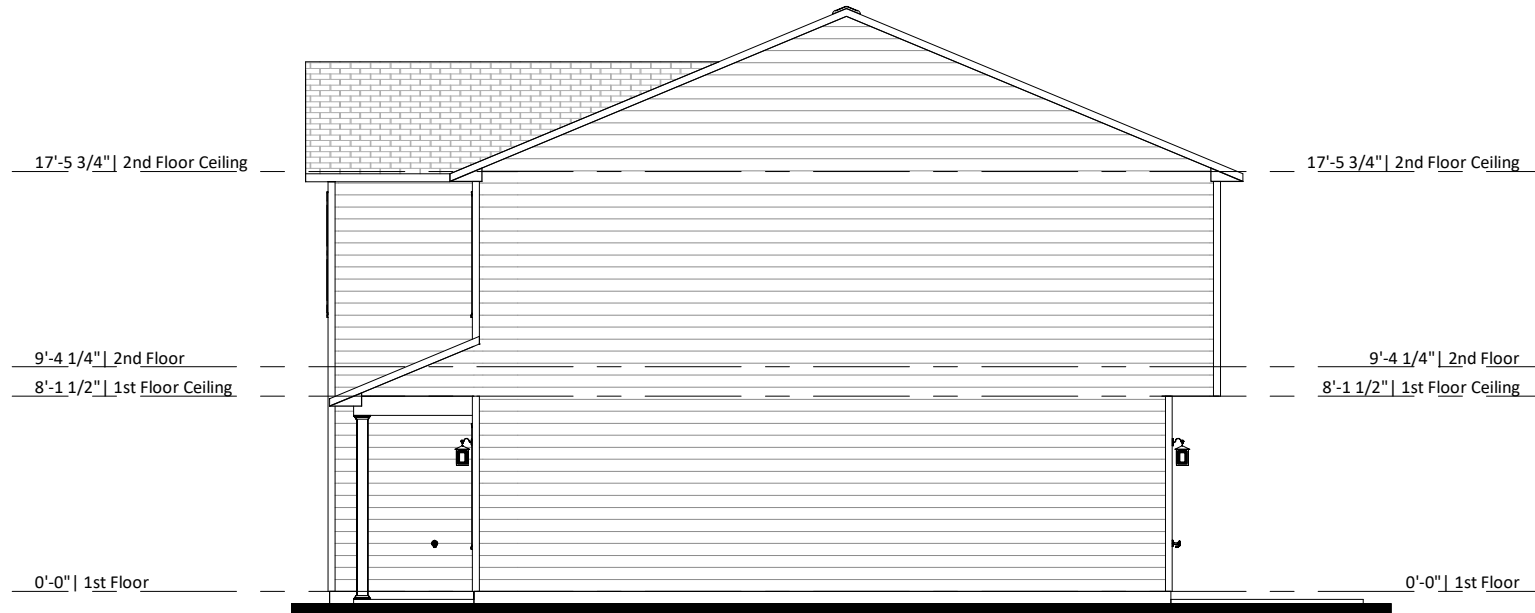

② Right Elevation - Elev A - 1 Car Garage
1/8" = 1'-0"

1710 LH - Elevation A 1Car

Side Elevations

Lot #:

Job #:

Address:


Community:

Last Revision Date:
11-18-21


Sheet #:
ElevA-1Car-Pg2



CONTRACTOR AND BUILDER SHALL REVIEW ENTIRE PLAN TO VERIFY CONFORMANCE WITH ALL CURRENT APPLICABLE CODES IN EFFECT AT TIME OF CONSTRUCTION. BY USING THESE DRAWINGS FOR CONSTRUCTION IT IS UNDERSTOOD THAT CONFORMANCE WITH ALL APPLICABLE CODES IS THE RESPONSIBILITY OF THE BUILDER AND CONTRACTOR.

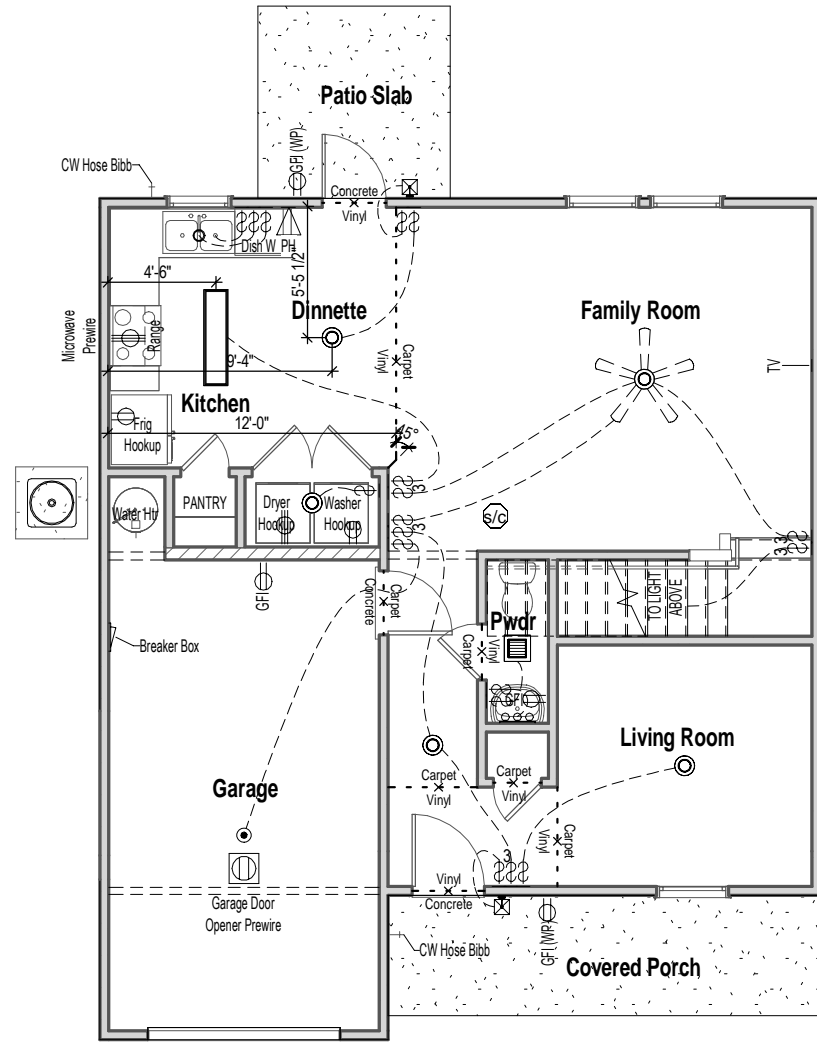

① 1st Floor Electrical - Elev A - 1 Car Garage
1/8" = 1'-0"

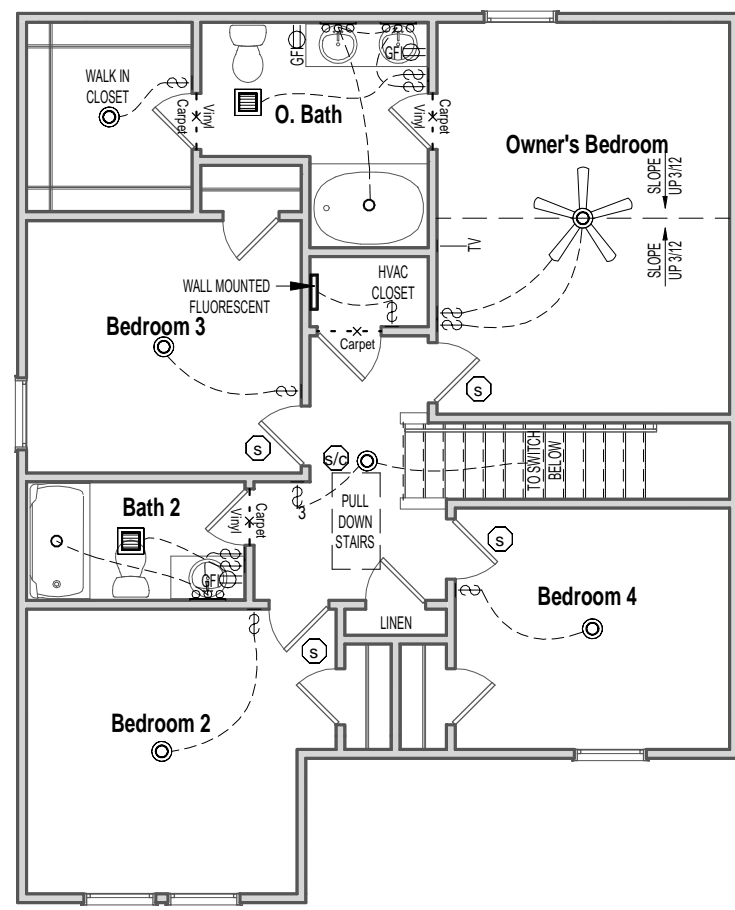

② 2nd Floor Electrical - Elev A - 1 Car Garage
1/8" = 1'-0"

WALL MOUNTED FIXTURES			CEILING MOUNTED FIXTURES		
OUTLET - 110V	OUTLET - TV	WALL LIGHT	GARAGE DOOR OPENER PREWIRE	SMOKE DETECTOR	
OUTLET - 110V GROUND FAULT INTERRUPTER	OUTLET - PHONE	18" LIGHT BAR	FLUSH MOUNT	SMOKE DETECTOR/CO2	
OUTLET - 110V GROUND FAULT INTERRUPTER WATER PROOF	SWITCH - SINGLE POLE	COACH LIGHT - FRONT DOOR	SURFACE CAN LIGHT	BATHROOM EXHAUST FAN	
OUTLET - 220V	SWITCH - 3 WAY	COACH LIGHT - REAR DOOR	FLUSH MOUNT W-FAN PREWIRE	FLUSH MOUNT W-FAN	
FLUORESCENT 1'x4' 2 LAMPS	SWITCH - 4 WAY	KEYLESS			

Outlets shown on the electrical layout are in addition to the outlets that shall be provided in accordance with International Residential Code Sections E3901.2 through E3901.11.

1710 LH - Elevation A 1Car

Electrical & Flooring Plan

Lot #:

Job #:

Address:

Community:

Last Revision Date:
11-18-21

Sheet #:
ElevA-1Car-Pg6